


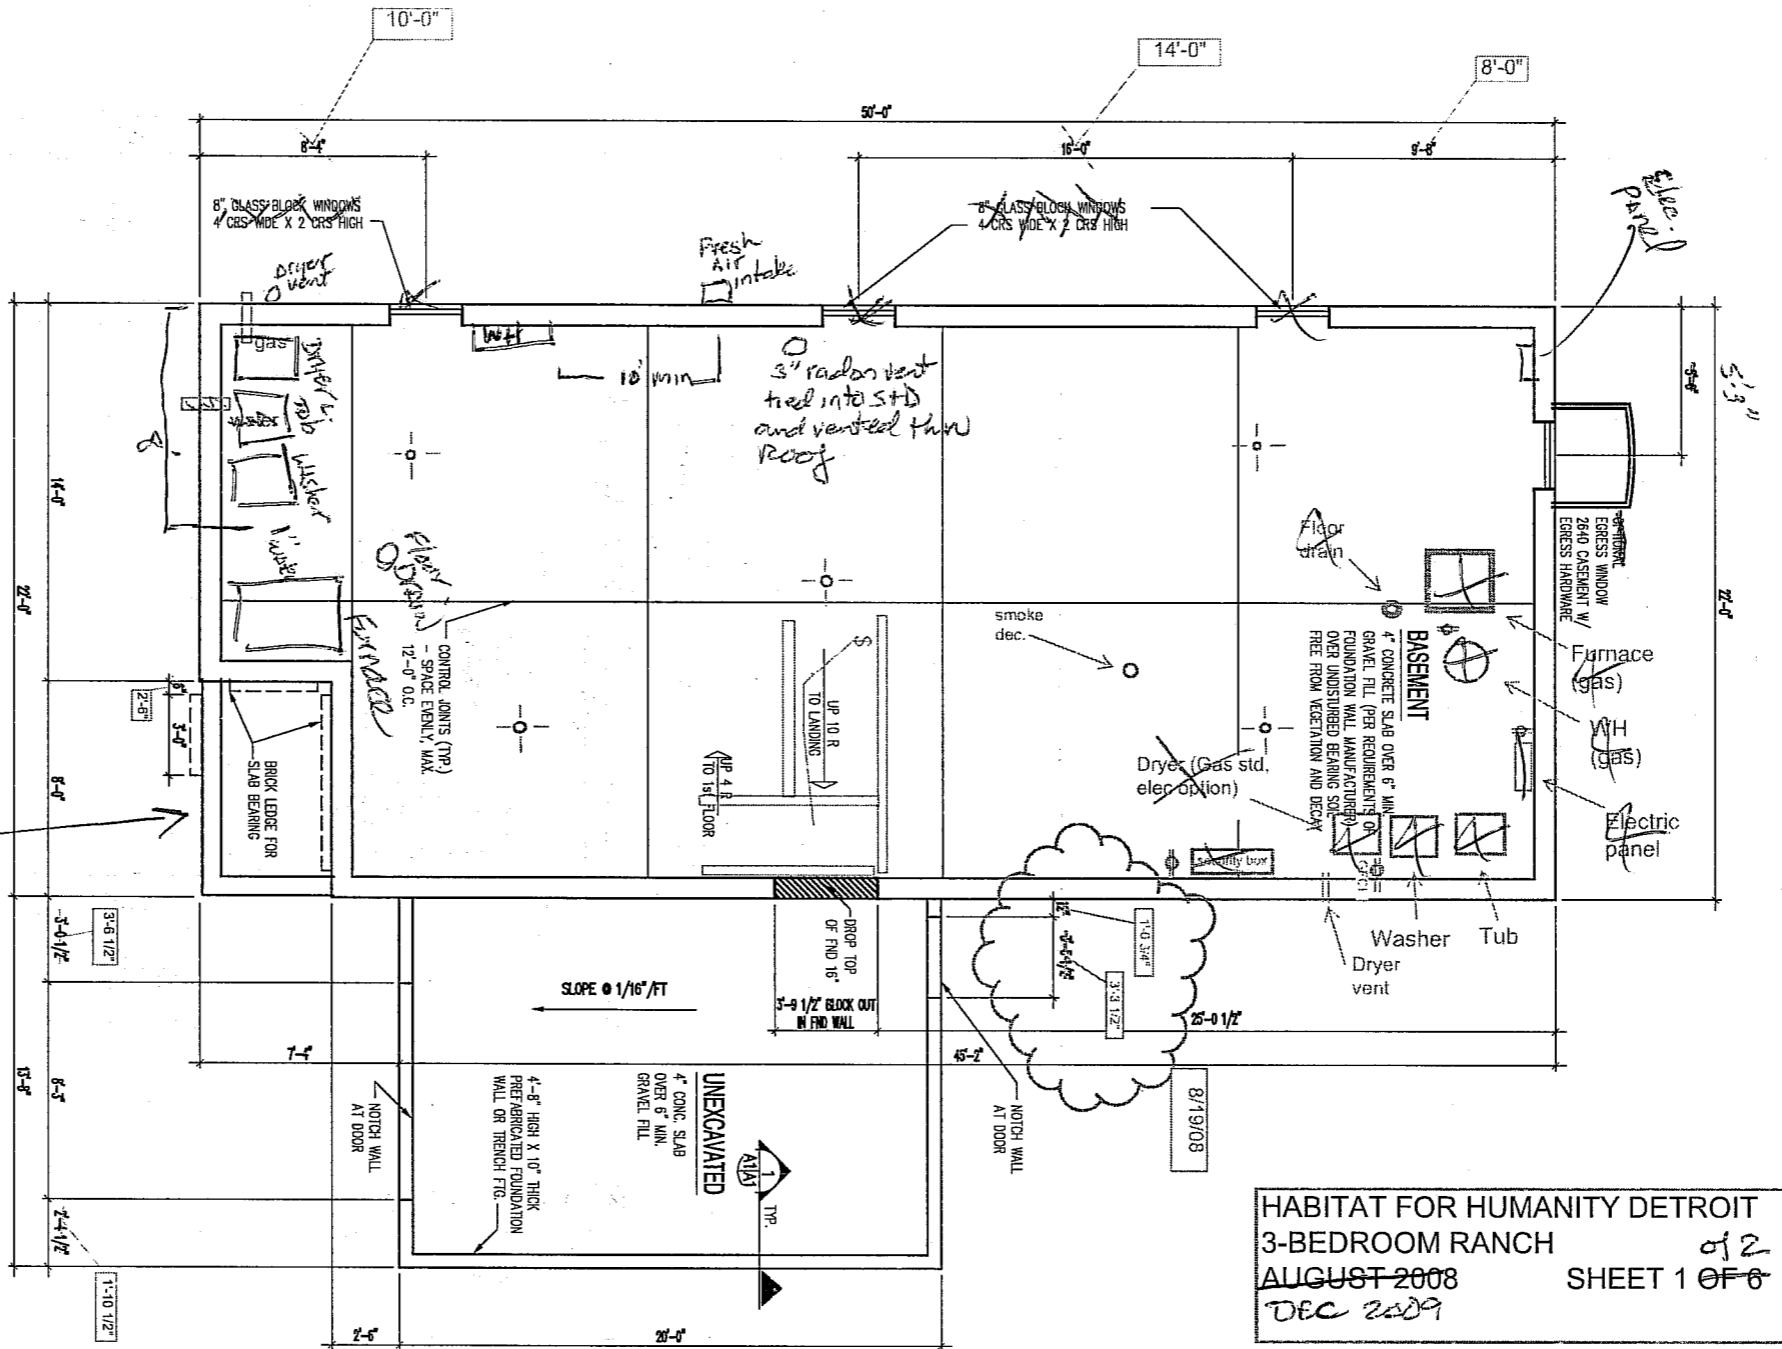


FOUNDATION PLAN

SCALE: 1/4" = 1'-0"

*Lead wall for
Steps & Landings*



HABITAT FOR HUMANITY DETROIT
3-BEDROOM RANCH
AUGUST 2008
DEC 2009
SHEET 1 OF 6

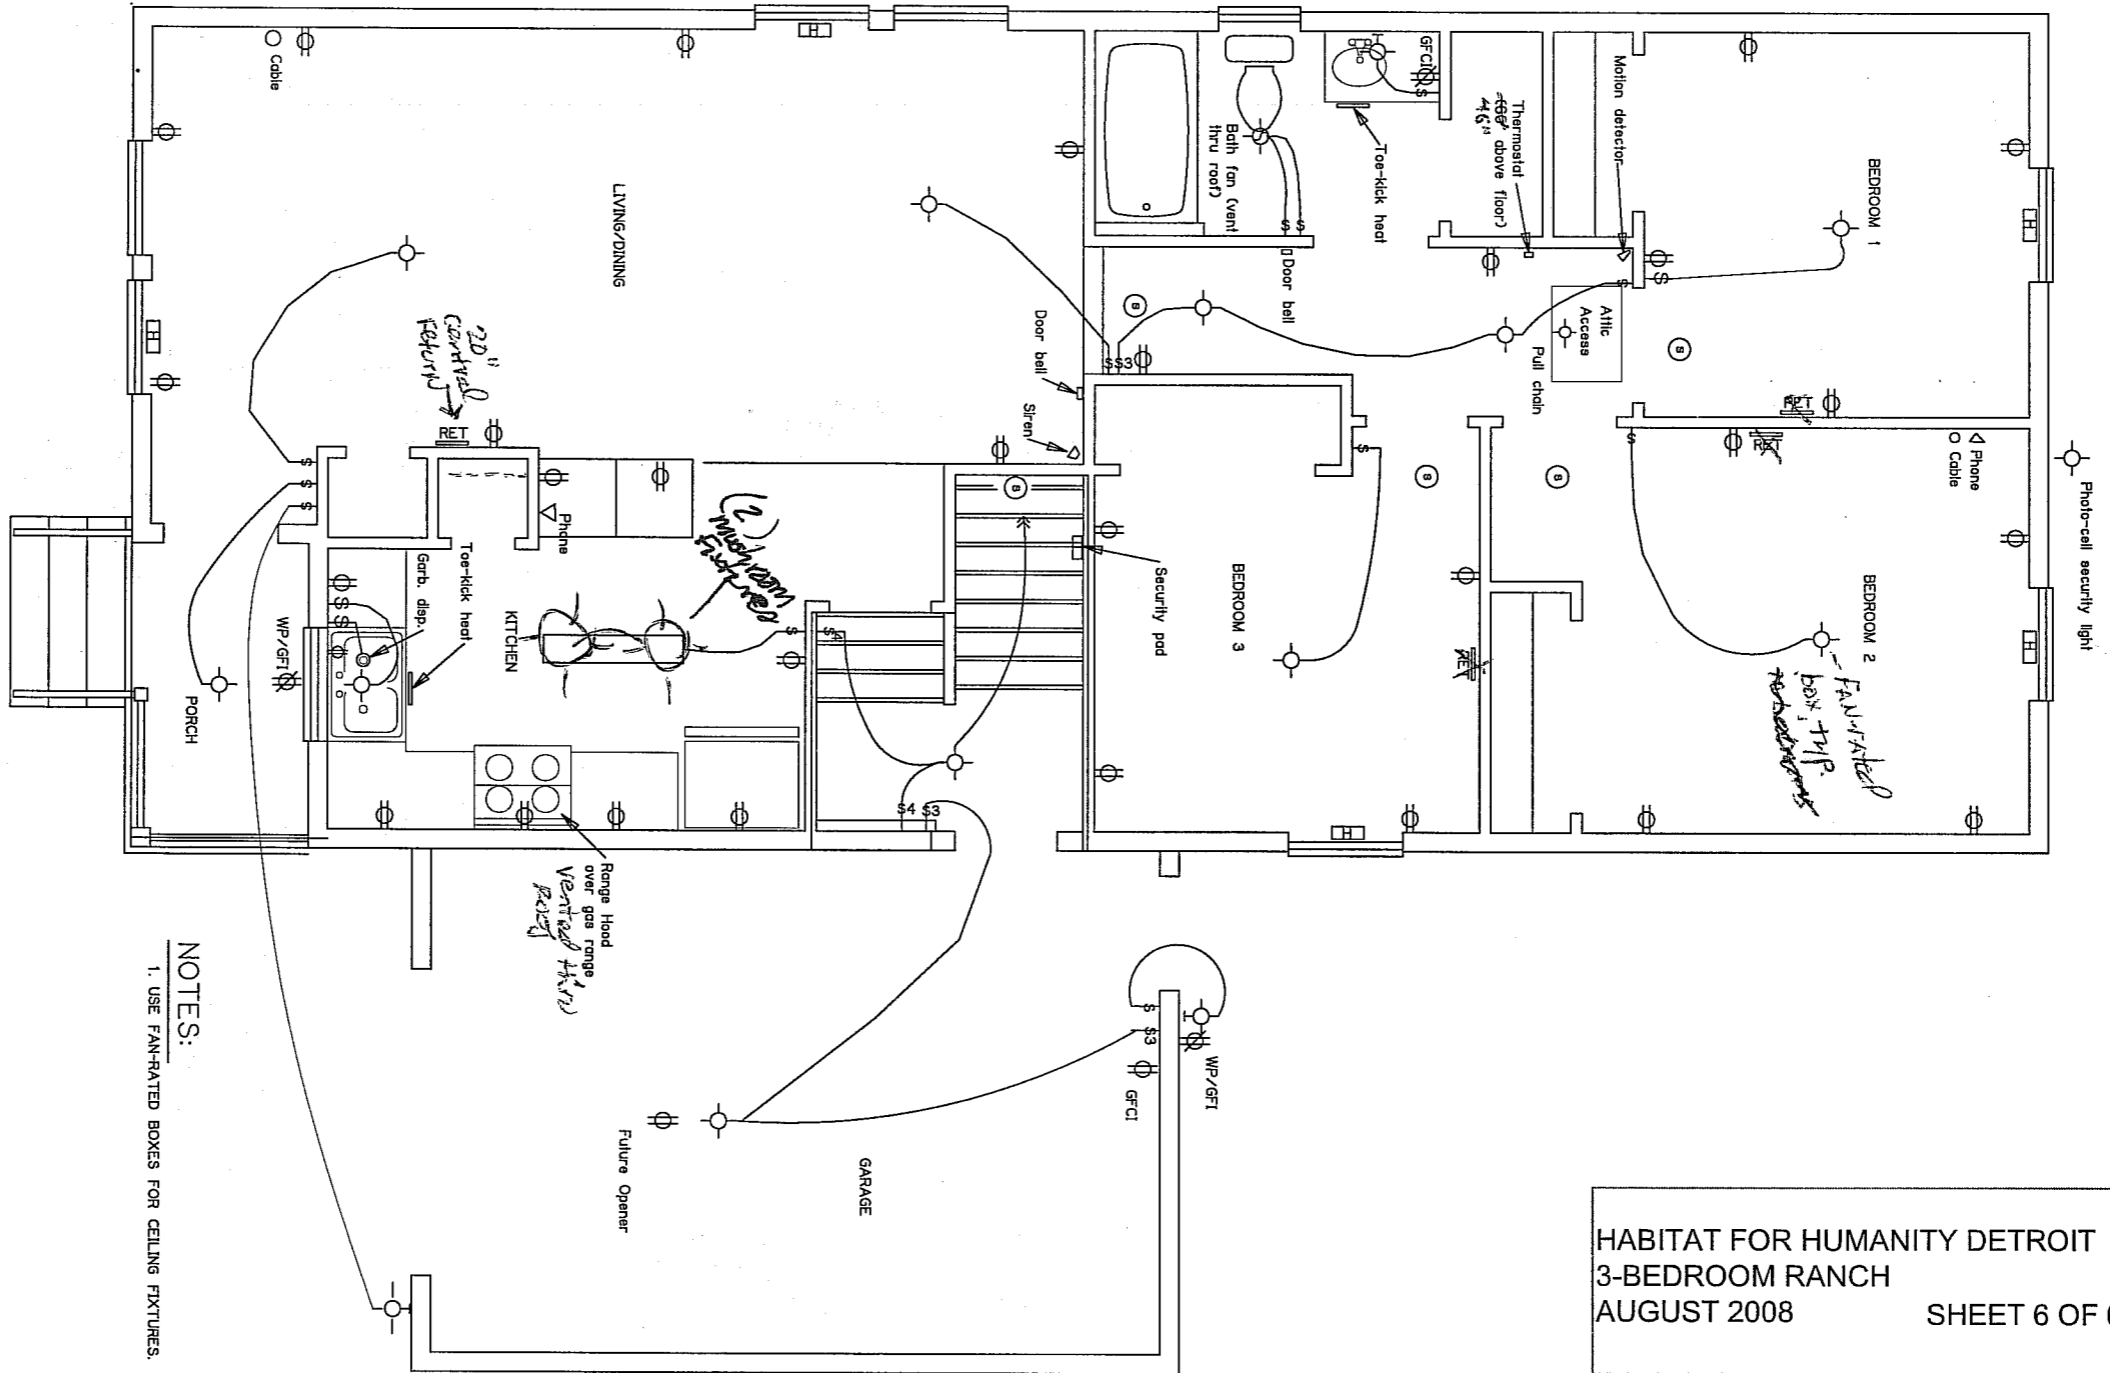

NOTES:
 1. USE FAN-RATED BOXES FOR CEILING FIXTURES.

ELECTRIC AND HEATING PLAN
 FIRST FLOOR

HABITAT FOR HUMANITY DETROIT
 3-BEDROOM RANCH W/ GARAGE
 JULY-2008- DEC 2009
 SHEET 2 of 2

HABITAT FOR HUMANITY DETROIT
 3-BEDROOM RANCH
 AUGUST 2008 SHEET 6 OF 6